



**SWM POND 32**  
BLOCK 18, PLAN 20M-1185

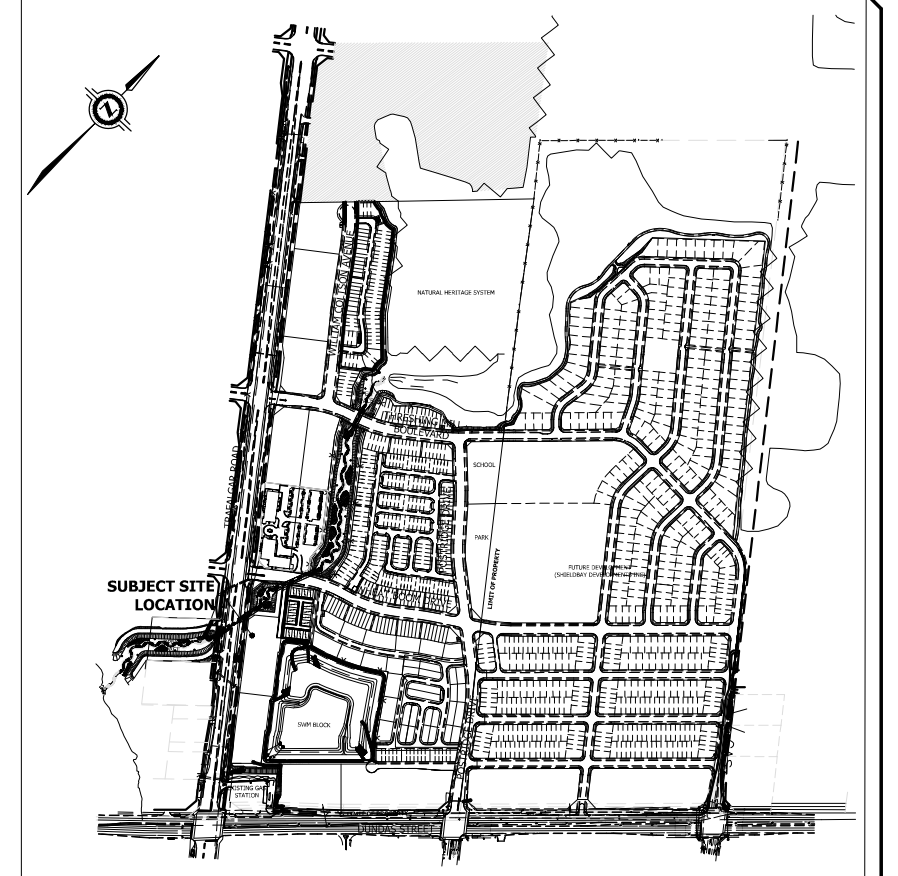

**KEY PLAN**  
N.T.S.

- LEGEND**
- BLOCK LIMIT/PROPERTY LIMIT
  - CONCRETE CURB, TWO-STAGE BARRIER (TOWN STD. 6-1)
  - CONCRETE CURB, MOUNTABLE (OPSD 600.050)
  - STORM SEWER AND MANHOLE
  - FUTURE SANITARY SEWER AND MANHOLE (DO-1069)
  - EXISTING STORM MANHOLE
  - FUTURE WATERMAIN (DO-1069)
  - TRANSFORMER
  - AREA DRAIN
  - CATCH BASIN
  - EXISTING SINGLE CATCHBASIN
  - EXISTING DOUBLE CATCHBASIN
  - PROP. HYDRANT & VALVE
  - FUT. HYDRANT & VALVE
  - VALVE AND BOX
  - FIRE DEPARTMENT CONNECTION
  - FUTURE CURB AS PER 'ISSUED FOR 30% REVIEW' PLANS BY RVA

Plans and drawings approved pursuant to the Planning Act.  
Planning Services Department  
26 June 2023  
*[Signature]*  
Town of Oakville

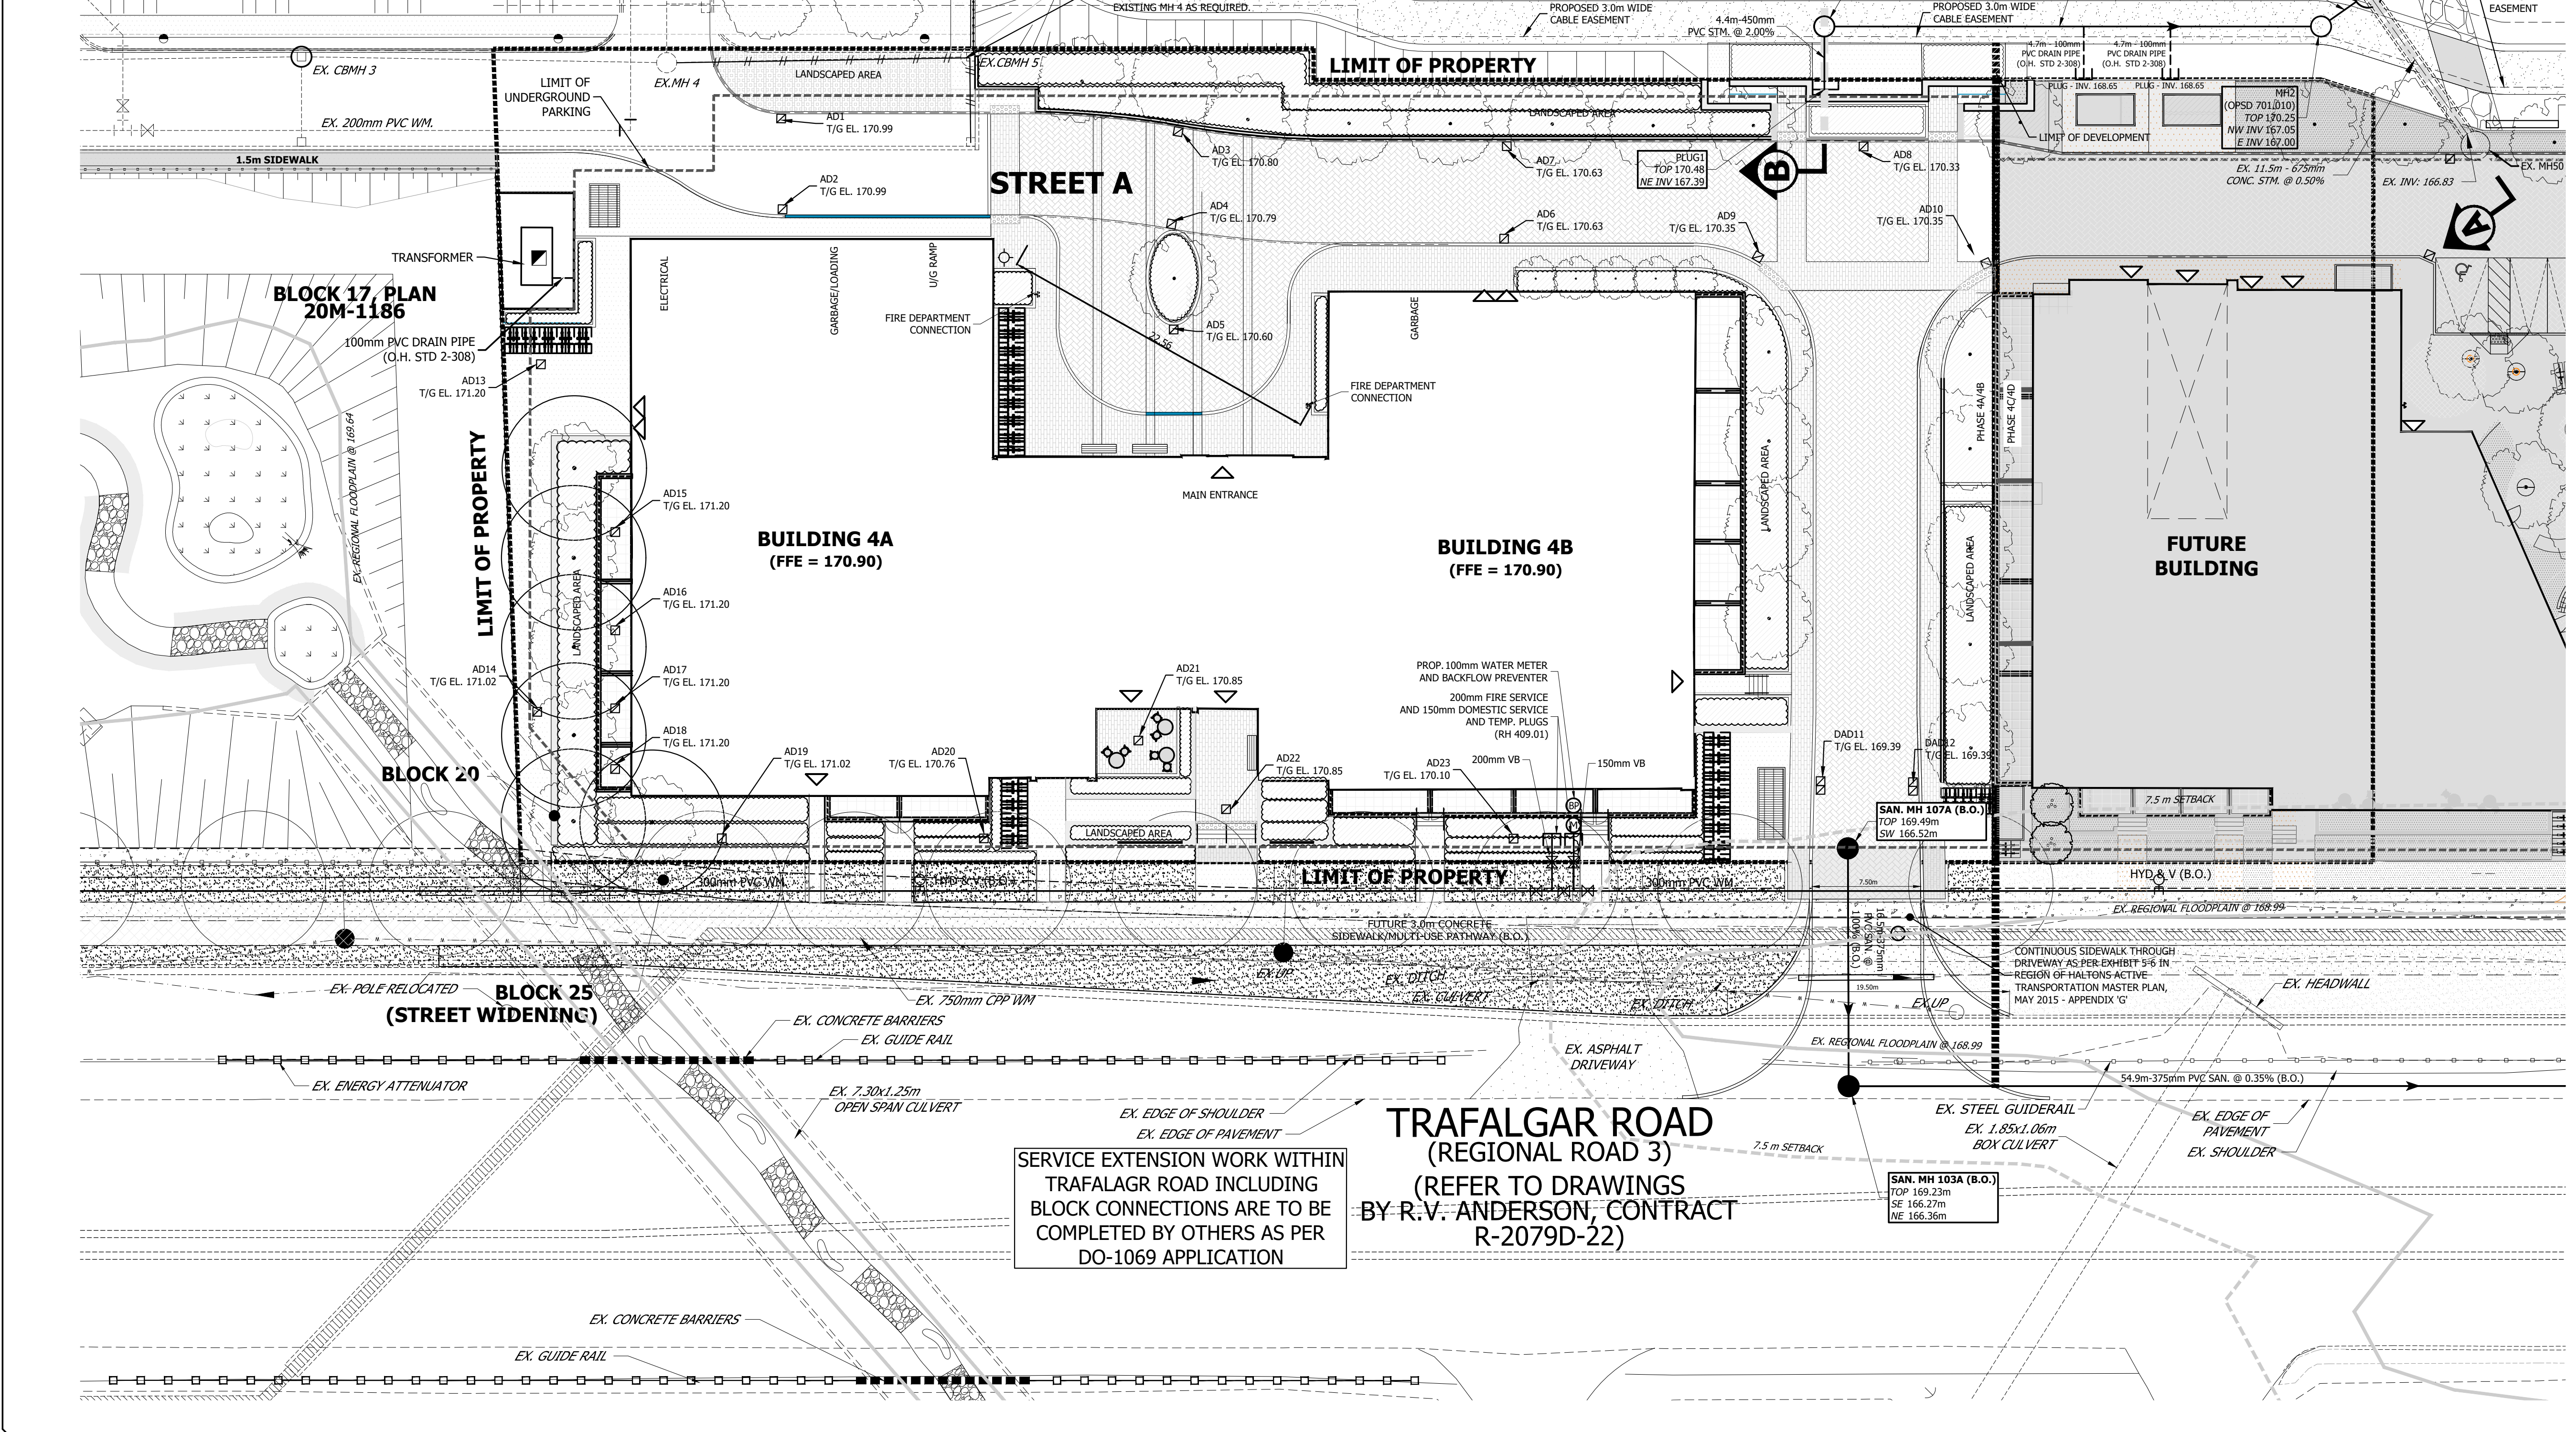

SERVICE EXTENSION WORK WITHIN TRAFALGAR ROAD INCLUDING BLOCK CONNECTIONS ARE TO BE COMPLETED BY OTHERS AS PER DO-1069 APPLICATION

**TRAFALGAR ROAD (REGIONAL ROAD 3)**  
(REFER TO DRAWINGS BY R.V. ANDERSON, CONTRACT R-2079D-22)

- NOTES:**
- FOR DETAILS OF EXISTING SEWERS REFER TO PROJECT 12-370 PHASE 2.
  - NEW WATER SERVICING TO BE BUILT WITH PHYSICAL SEPARATION FROM LIVE WATER SERVICING FOR TESTING PURPOSES.
  - ANY CONNECTION TO AN EXISTING SERVICE PREVIOUSLY INSTALLED SHALL BE SWABBED, FLUSHED AND SAMPLED BY THE REGION AT THE SOLE EXPENSE OF THE APPLICANT.

No.	REVISIONS	DATE	BY
4	SPA 4	APR. 2023	A.M.
3	SPA 3	DEC. 2022	A.M.
2	SPA 2	APR. 2022	J.O.
1	SPA 1	OCT. 2021	J.O.

**MINTO COMMUNITIES (TRAFALGAR AND DUNDAS) BLOCK 8, PLAN 20M-1211**

REGIONAL MUNICIPALITY OF HALTON  
**TOWN OF OAKVILLE**

REGION FILE No. \_\_\_\_\_  
SITE PLAN No. **SP.1312.012/02**

MUNICIPAL PLANNING No. _____	REGIONAL REGIONAL DESIGN OF WATER AND WASTEWATER SERVICES APPROVED SUBJECT TO FINAL CONSTRUCTION COMPENSATION TO HEALTHY REGION STANDARDS & SPECIFICATIONS & LOCATION APPROVAL FROM AREA MUNICIPALITY.
SIGNED: _____ DATE: _____	SIGNED: _____ DATE: _____
MANAGER OF DEVELOPMENT ENGINEERING	MANAGER OF DEVELOPMENT ENGINEERING

**urbantech**  
Infrastructure Planning & Policy  
100509390  
APR. 17, 2023

**SERVICING PLAN**

DESIGNED: D.Y.	CHECKED: A.M.	PROJECT No.: 20-651
DRAWN: D.Y.	DATE: APRIL 2023	SHEET No.:
SCALE: 1:250		DRAWING No.: <b>101</b>